



1 Floor Plan
Scale: 1/4"=1'

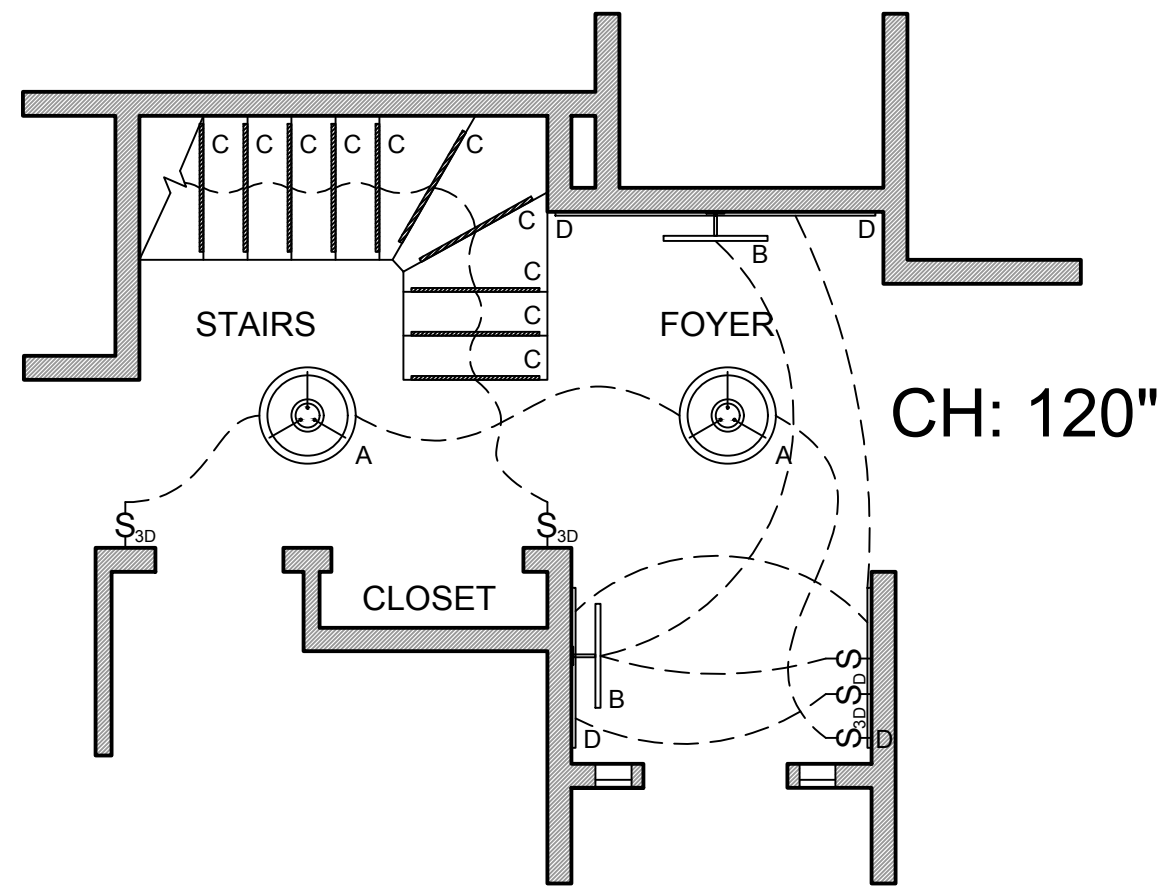

2 Reflected Ceiling Plan
Scale: 1/4"=1'

Symbol	Tag	Description	Voltage	Mfgr	Finish	SKU	Notes
	A	Round 23.5" LED pendant	120VAC	Elan Fornello	Black	5W164	
	B	Horizon 26" LED Picture Light	120VAC	House Of Troy	Oil Rubbed Bronze	DHLEDZ26	
	C	3' LED Strip Lights	LV	SuperNight	N/A	EBT452	Must be mounted in aluminum channels with diffuser (Y00M92IDZ6), cut to 2'8"
	D	1M LED Strip Lights	LV	SuperNight	N/A	EBT452	Must be mounted in aluminum channels with diffuser (Y00M92IDZ6)
	E	Duplex Outlet	120VAC	N/A	White	N/A	Installed 12" Above Finished Floor

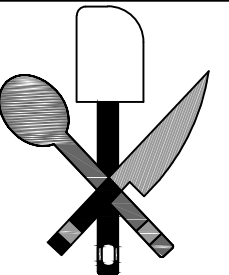

SHEET TITLE
LIGHTING PROJECT #1
A WORLD OF LIGHT

GRANT KIESER
ID 236 - LIGHTING DESIGN
FALL 2015 - PCC

SHEET NO:
1